


暖通工程
给排水工程
电气工程
弱电工程
装饰装修工程
园林景观工程
其他工程

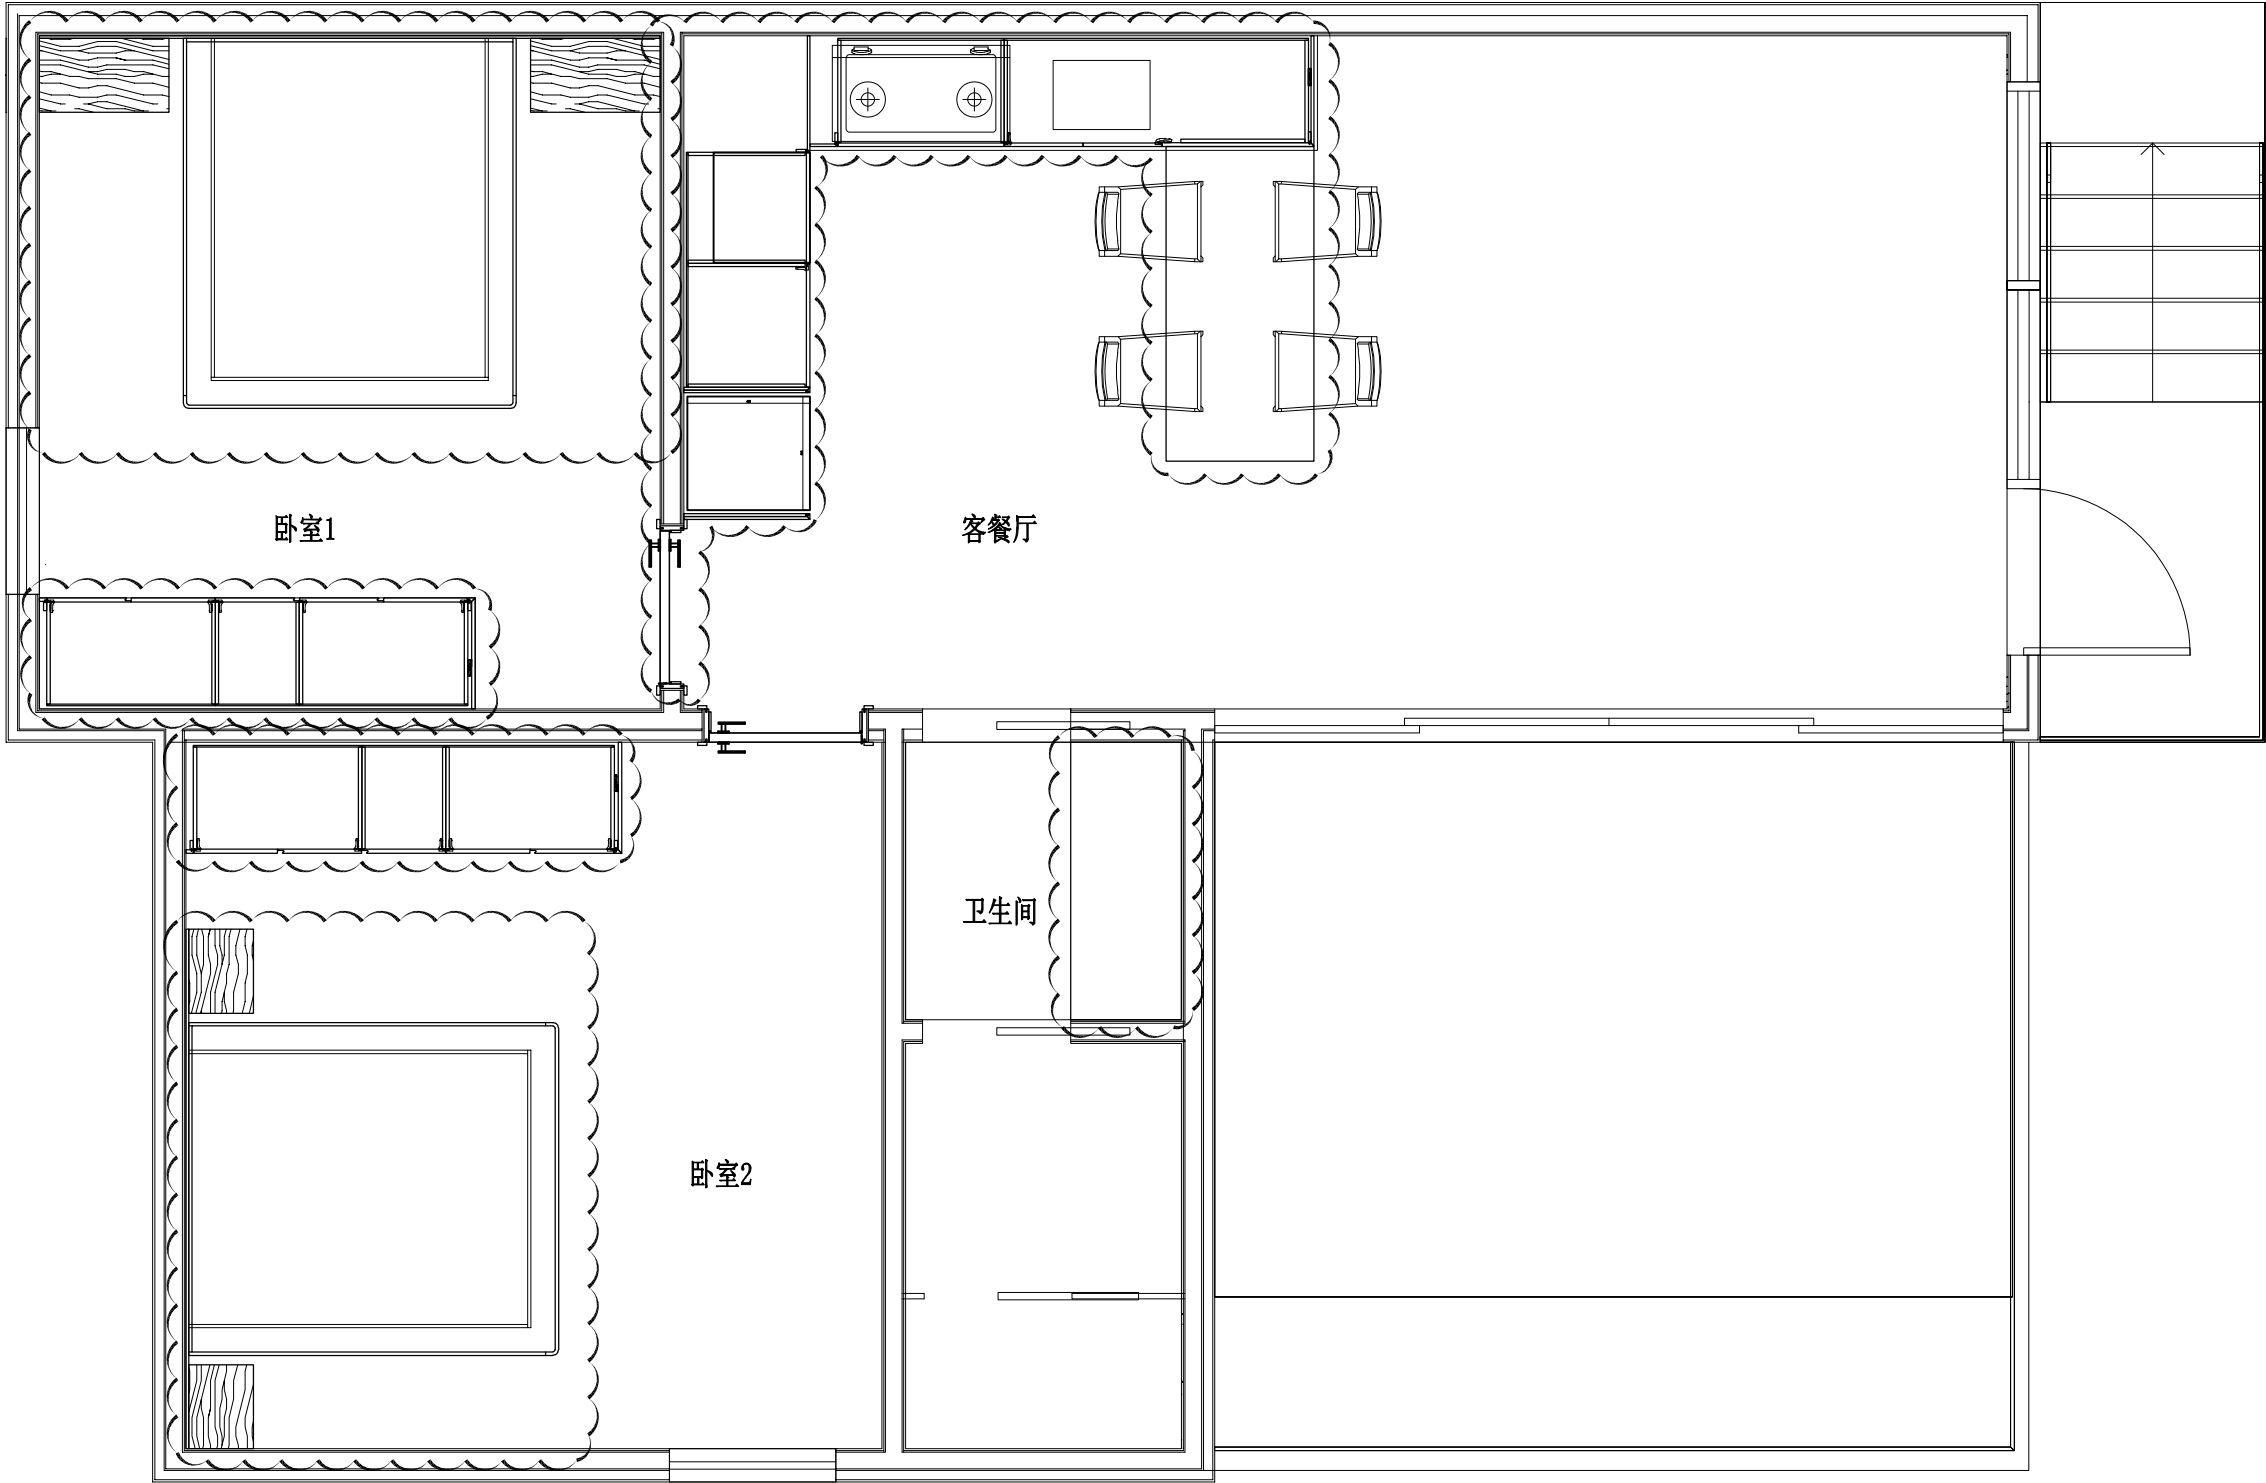

COPYRIGHT:
ALL RIGHTS RESERVED. THIS WORK IS COPYRIGHT AND CANNOT BE REPRODUCED OR COPIED BY ANY MEANS
WITHOUT THE WRITTEN PERMISSION OF BAHAMA HOUSEHOLD PVT LTD. ANY LICENSE, EXPRESS OR IMPLIED, TO
USE THIS DOCUMENT FOR ANY PURPOSES WITHOUT THE WRITTEN PERMISSION OF BAHAMA HOUSEHOLD PVT LTD. IS
HEREBY FORWARDED TO THE INSTRUCTING PARTY.

GENERAL NOTES:
USE DIMENSIONS IN PREFERENCE TO SCALE. CONFIRM THE
SCALE OF DIMENSIONS BY CONSULTING ALL
DIMENSIONS ON SITE BEFORE FABRICATION OR BEFORE SET OUT.

CLIENT 建设单位	PROJECT 项目名称
SUB-PROJECT 子项名称	


巴哈马别墅

PROJECT MANAGER 项目负责人	
DRAWN 制图	AUDIT 审核
DESIGN 设计	CHECKED 审定
VERIFY 校对	


TITLE 图纸名称	
DRAWING NO. 图号	

DISCIPLINE 专业	
STATUS 阶段	
SCALE 比例	1:20
DATE 日期	


暖通工程
给排水工程
电气工程
弱电工程
装饰工程
园林景观工程
其他工程

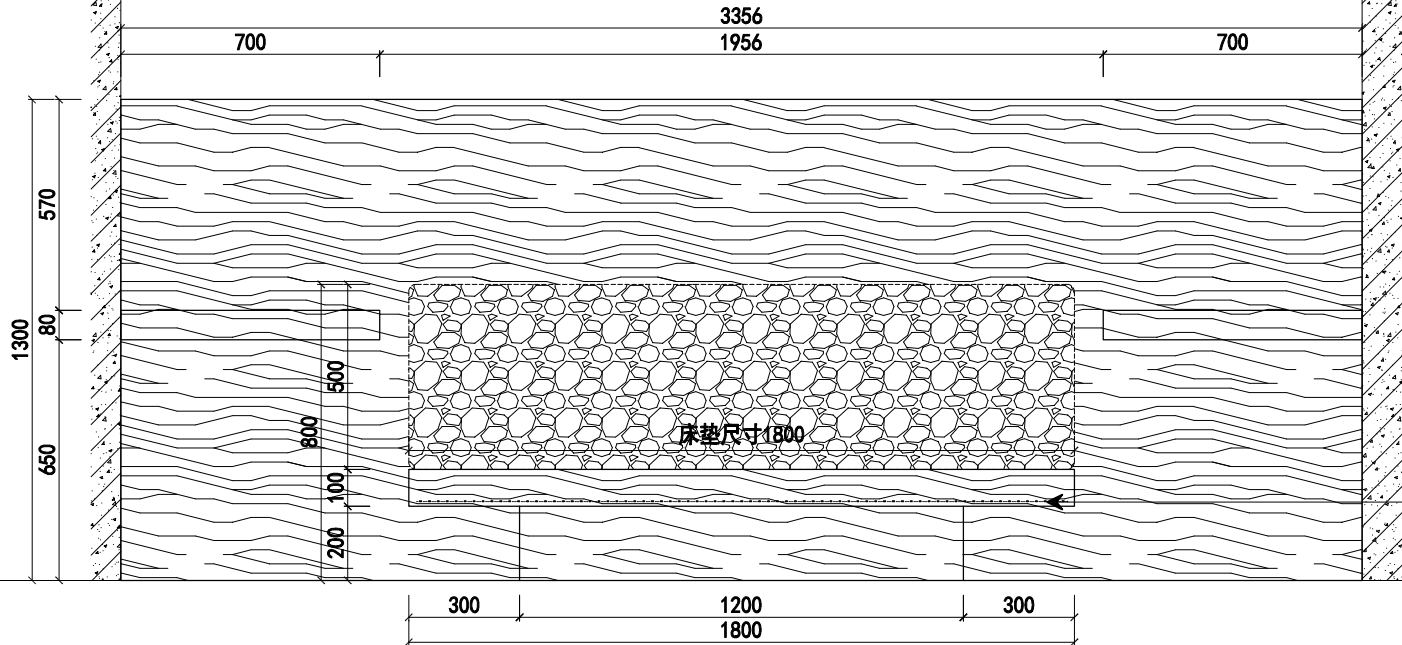

1 正立面图
比例(A3)1:6

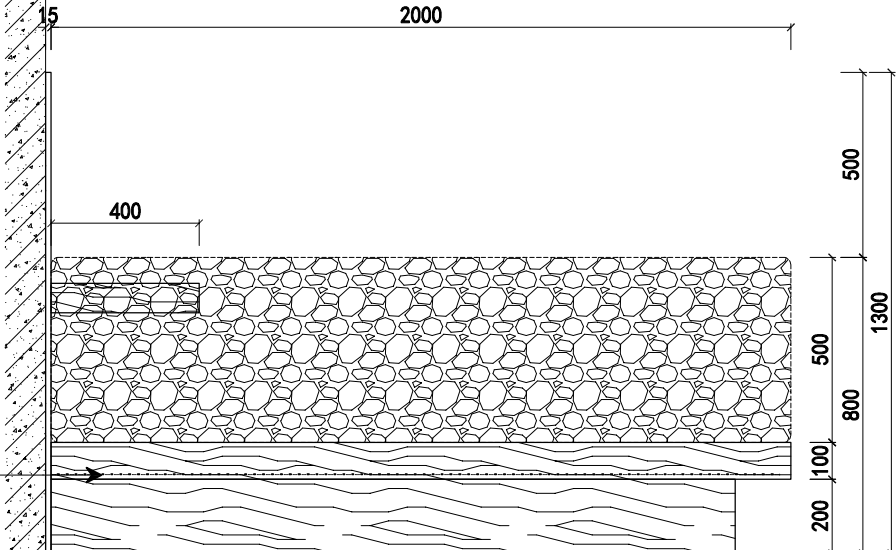

3 侧立面图
比例(A3)1:6

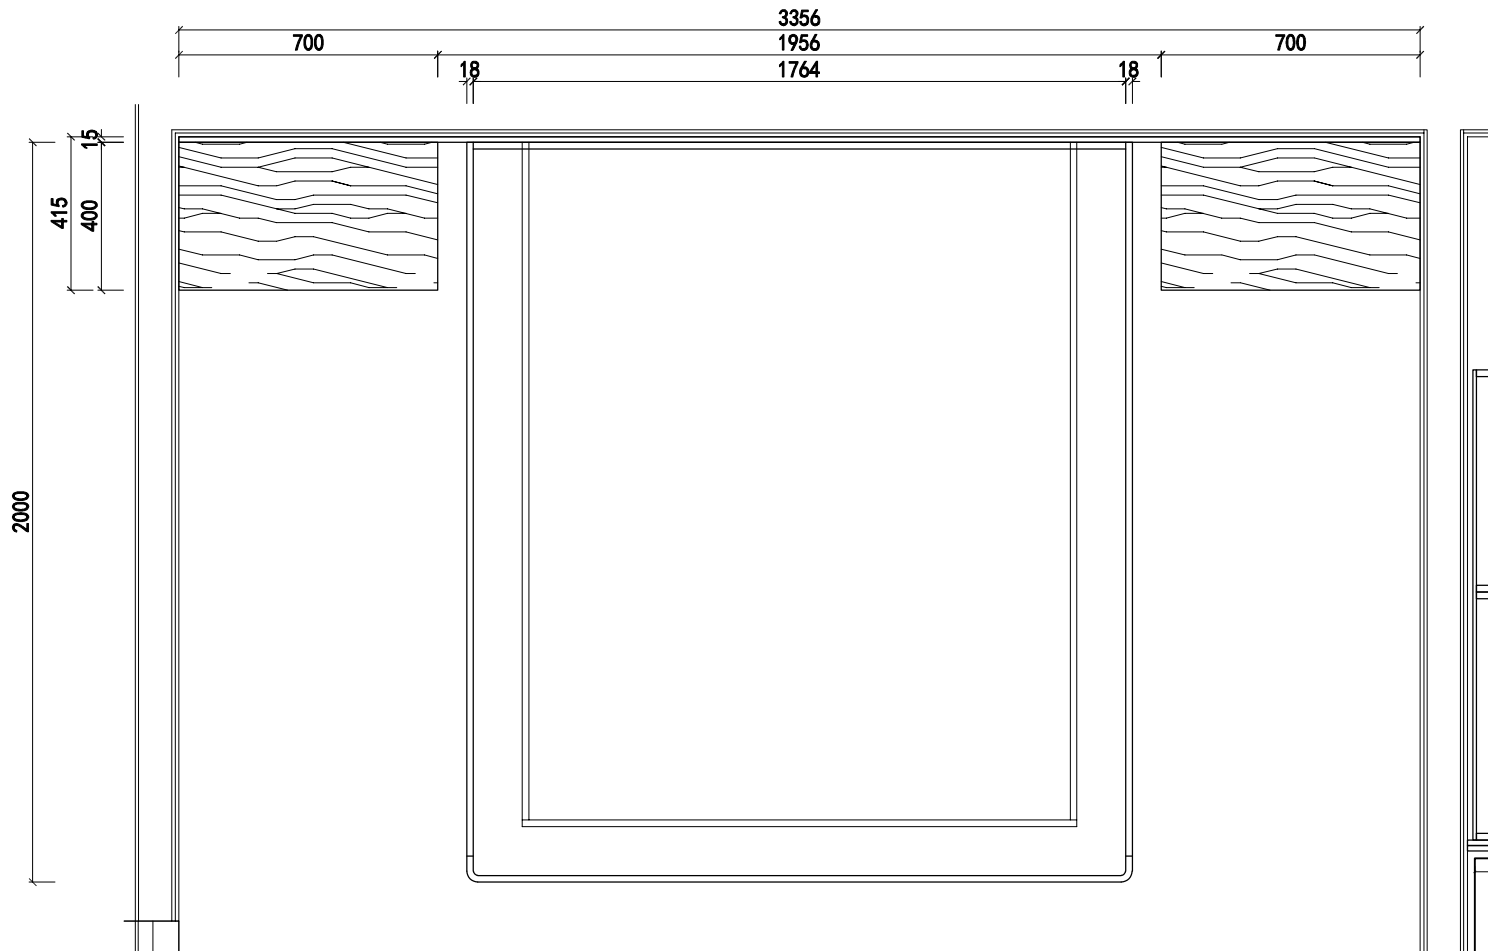

2 X1剖面结构图
比例(A3)1:6



COPYRIGHT:
ALL RIGHTS RESERVED. THIS WORK IS COPYRIGHT AND CANNOT BE REPRODUCED OR COPIED BY ANY MEANS
WITHOUT THE WRITTEN PERMISSION OF BAHAMA HOUSEHOLD PVT LTD. ANY LICENSE, EXPRESS OR IMPLIED, TO
USE THIS DOCUMENT FOR ANY PURPOSES WITHOUT THE WRITTEN PERMISSION OF BAHAMA HOUSEHOLD PVT LTD.
AGREEMENT BETWEEN BAHAMA HOUSEHOLD PVT LTD AND THE INSTRUCTING PARTY.





GENERAL NOTES:
USE PICTURED DIMENSIONS IN PREFERENCE TO SCALED. CONFIRM THE
SCALE & DIMENSIONS OF DIMENSIONS BY CONSIDERING ALL
DIMENSIONS ON SITE BEFORE FABRICATION OR BEFORE SET OUT.


CLIENT 建设单位	PROJECT 项目名称	巴哈马别墅
	SUB-PRO. 子项名称	卧室1

PROJECT MANAGER 项目负责人:	
DRAWN 制图:	AUDIT 审核:
DESIGN 设计:	CHECKED 审定:
VERIFY 校对:	


TITLE 图纸名称:	DISCIPLINE 专业:
DRAWING NO. 图号:	STATUS 阶段:
DATE 日期:	SCALE 比例: 20

    建筑结构工程
建设电通




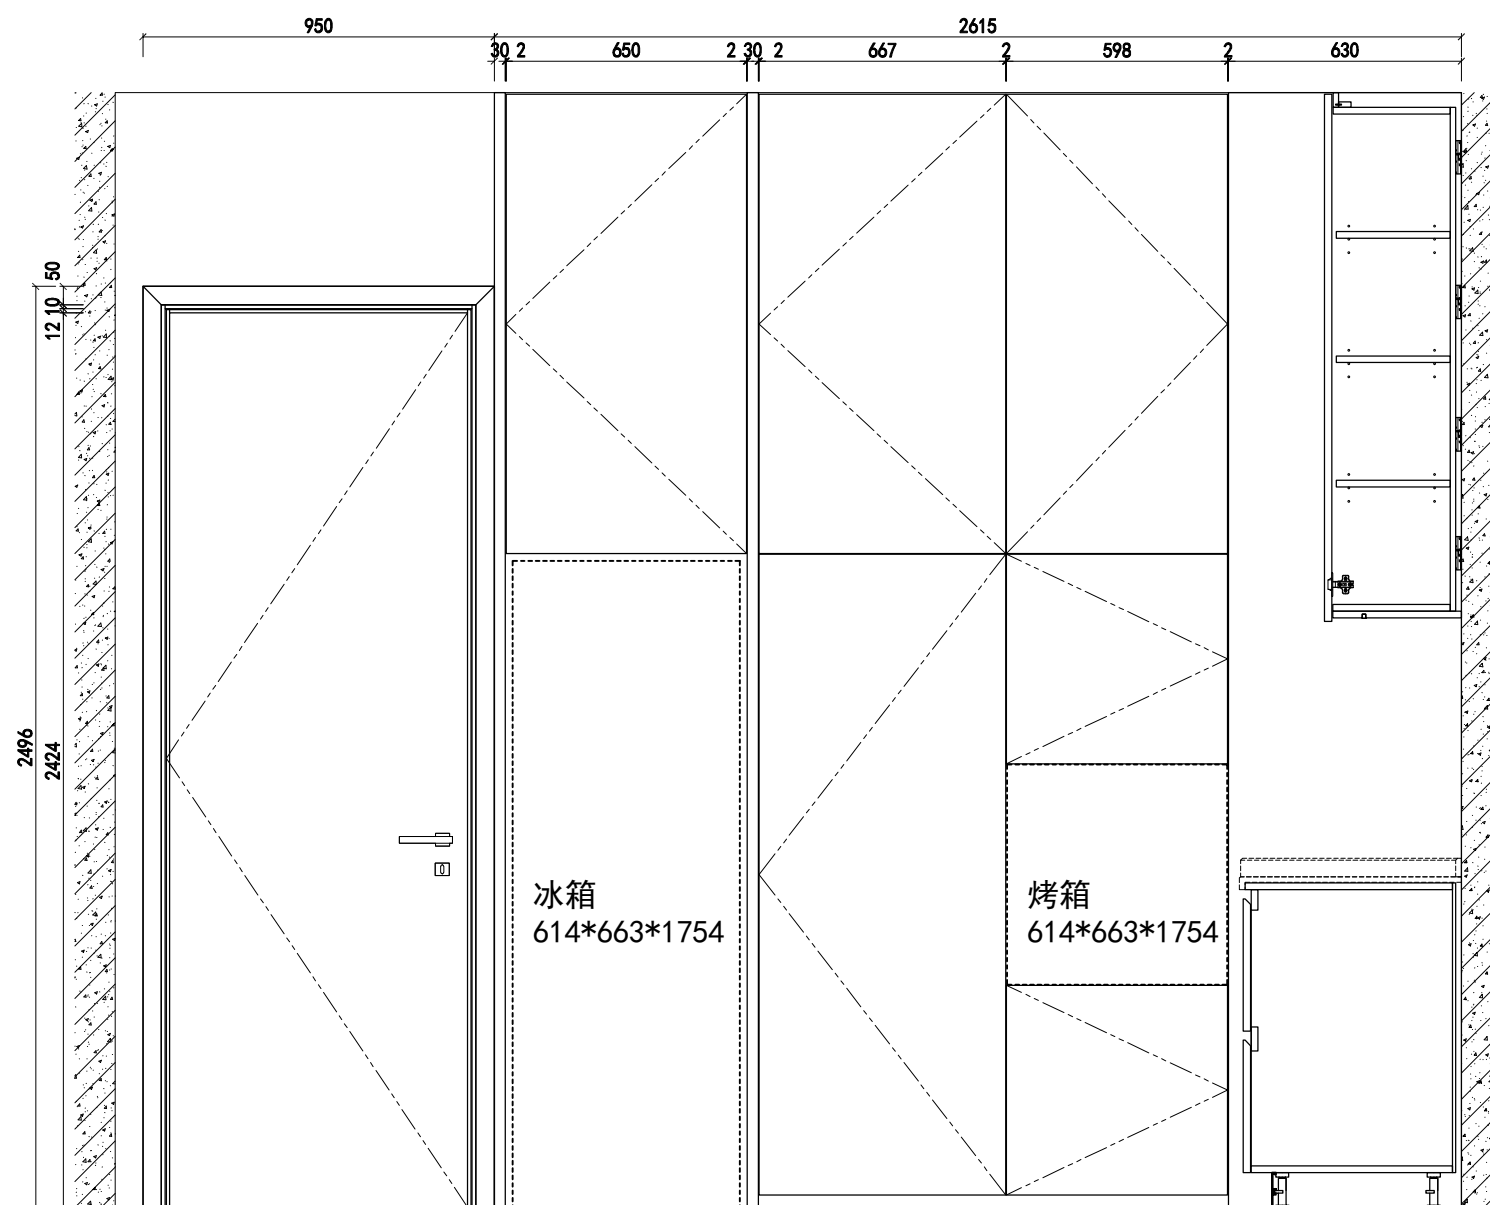[illegible]


① 正立面图
比例(A3) 1:6

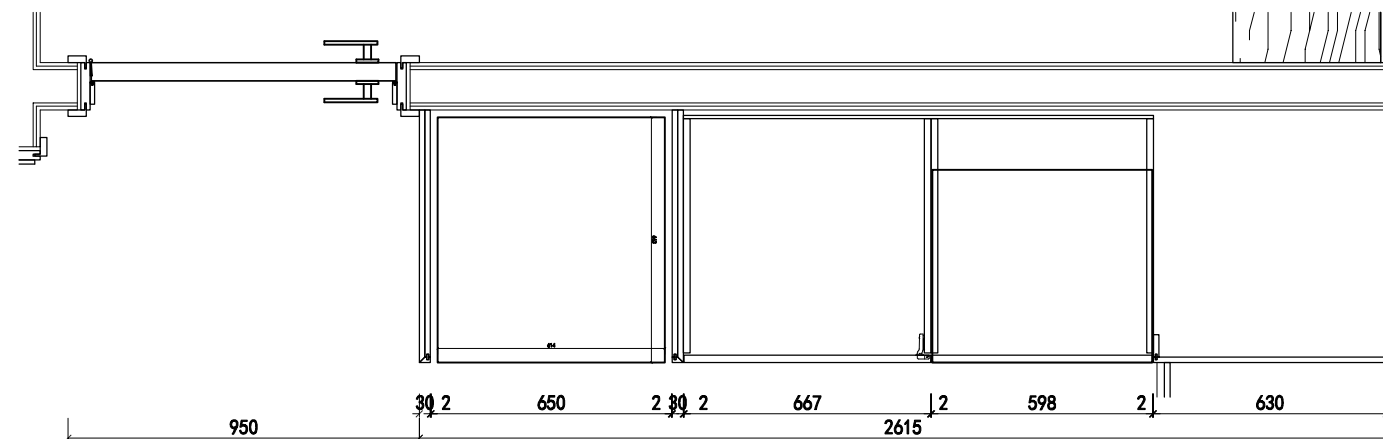



② X1剖面结构图
比例(A3) 1:6

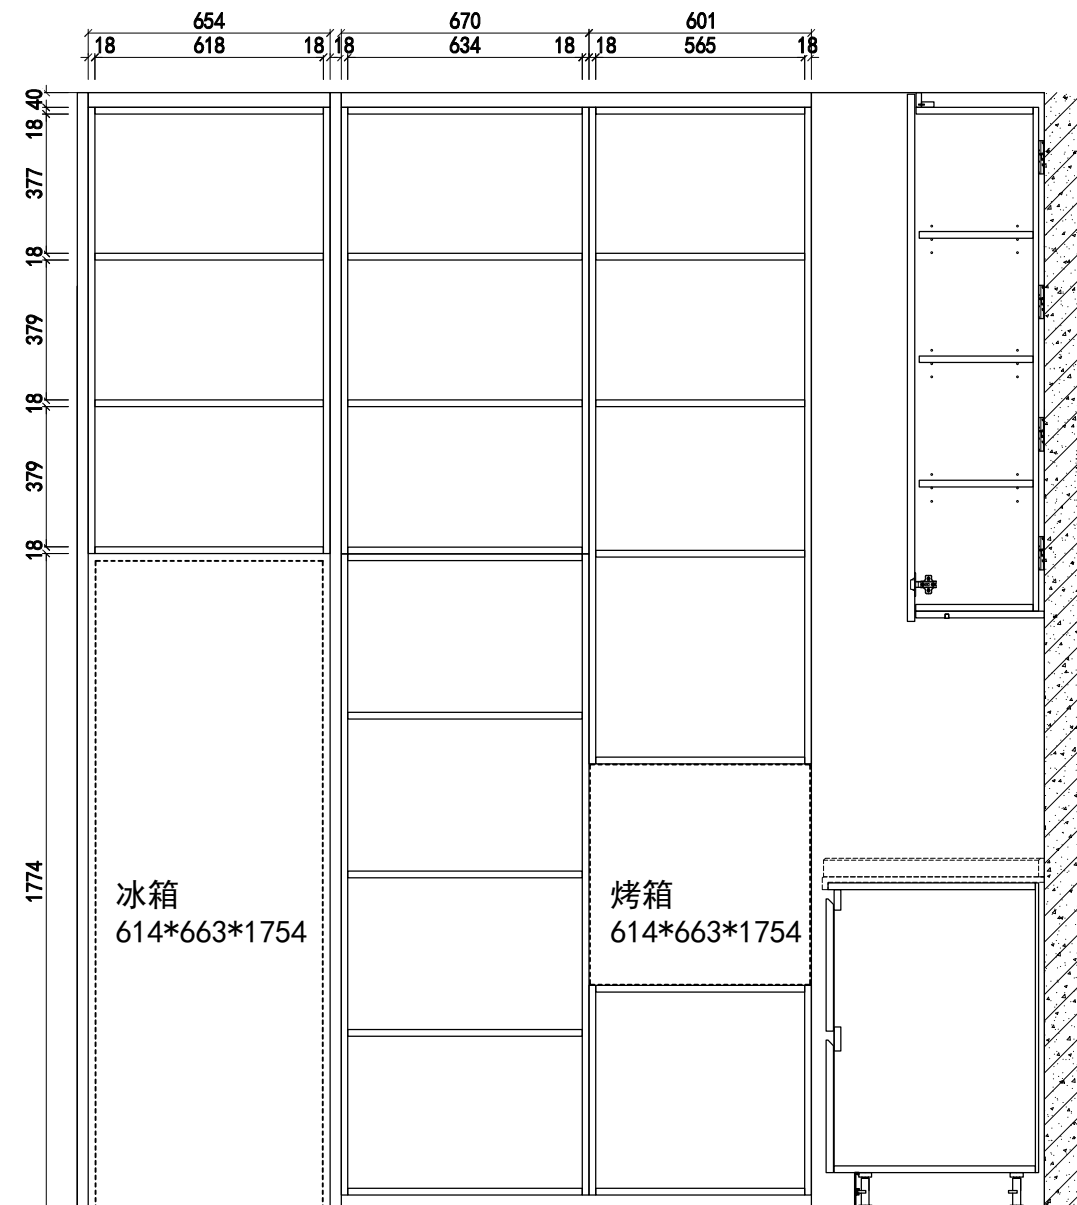


③ 内笼图
比例 (A3) 1:6

 


① 正立面图
比例(A3) 1:6

  

建筑电气	给排水工程	暖通工程	
建筑电气工程	给排水工程	暖通工程	
建筑电气工程	给排水工程	暖通工程	
建筑电气工程	给排水工程	暖通工程	

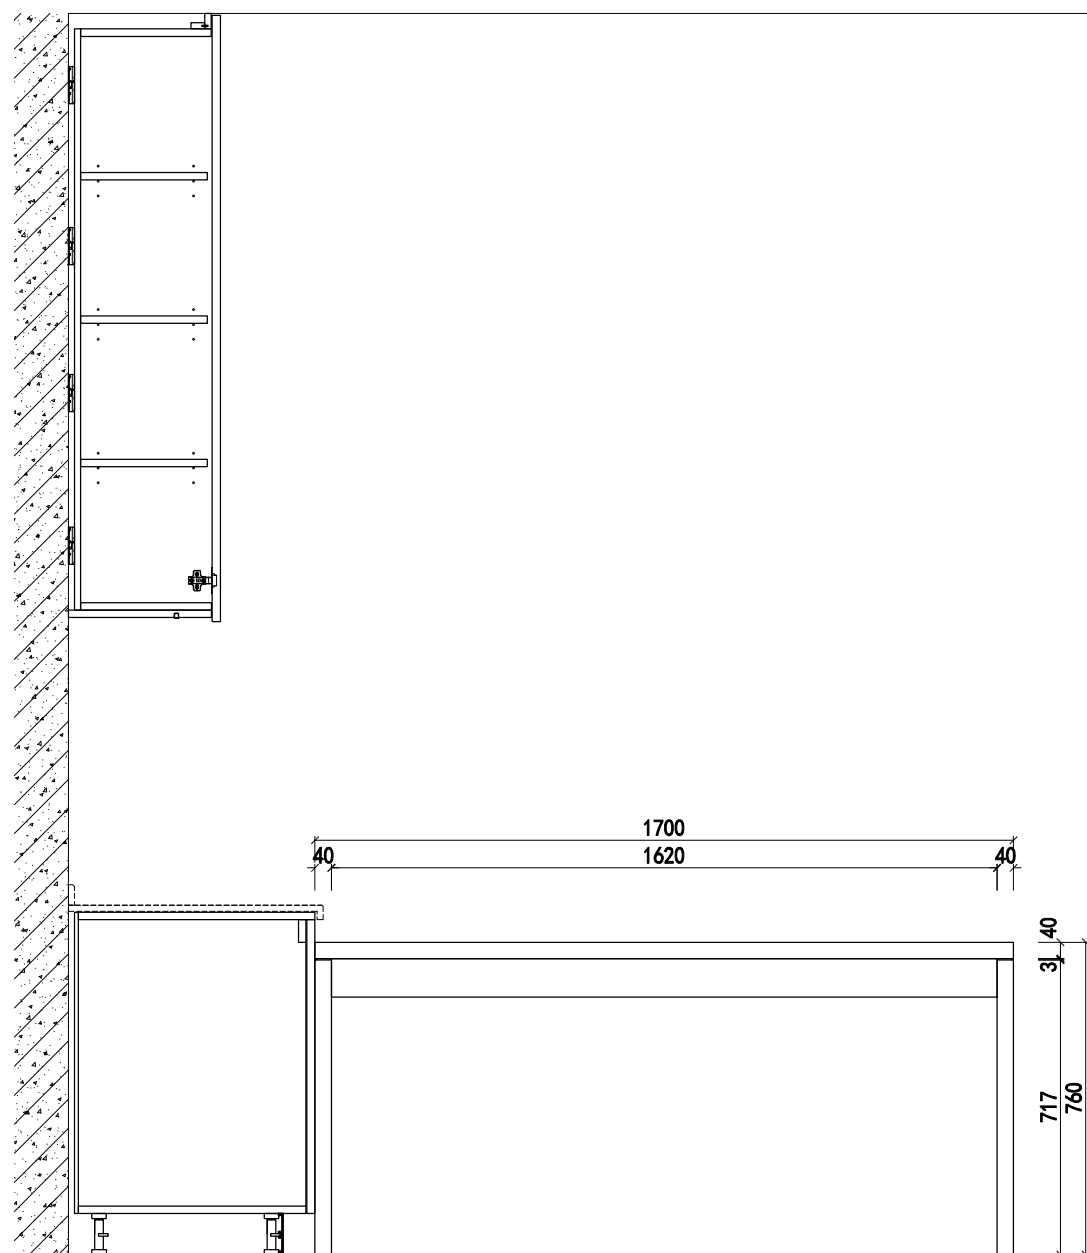

① 正立面图
比例(A3) 1:6

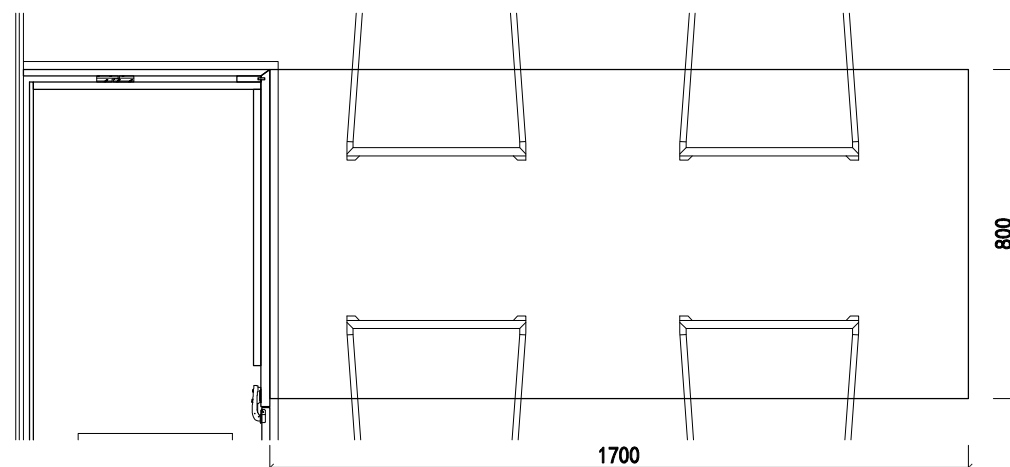

② X1剖面结构图
比例(A3) 1:6




COPYRIGHT:
ALL RIGHTS RESERVED. THIS WORK IS COPYRIGHT AND CANNOT BE REPRODUCED OR COPIED BY ANY MEANS WITHOUT THE WRITTEN PERMISSION OF RUJACH INDUSTRIES PTY LTD. ANY LICENSE, EXPRESS OR IMPLIED, TO USE THIS DOCUMENT FOR ANY PURPOSE WHATSOEVER IS RESTRICTED TO THE TERMS OF THE AGREEMENT BETWEEN RUJACH INDUSTRIES PTY LTD AND THE INSTRUCTING PARTY.


GENERAL NOTES:
USE FIGURED DIMENSIONS IN PREFERENCE TO SCALED. CONFIRM THE SCALE F HARD COPY DRAWINGS BY USING BAR CHECK ALL DIMENSIONS ON SITE BEFORE FABRICATION OR BEFORE SET OUT.

CLIENT 建设单位	PROJECT 项目名称	巴哈马别墅		PROJECT MANAGER 项目负责人:			TITLE 图纸名称:	DISCIPLINE 专业:
	SUB-PROJ 子项目名称	客餐厅		DRAWN 制图:	AUDIT 审核:			STATUS 阶段:
				DESIGN 设计:	CHECKED 审定:			SCALE 比例: 20
				VERIFY 校对:			DRAWING NO. 图号:	DATE 日期:

建筑电气	给排水工程	暖通工程	
建筑电气工程	给排水工程	暖通工程	
建筑电气工程	给排水工程	暖通工程	
建筑电气工程	给排水工程	暖通工程	

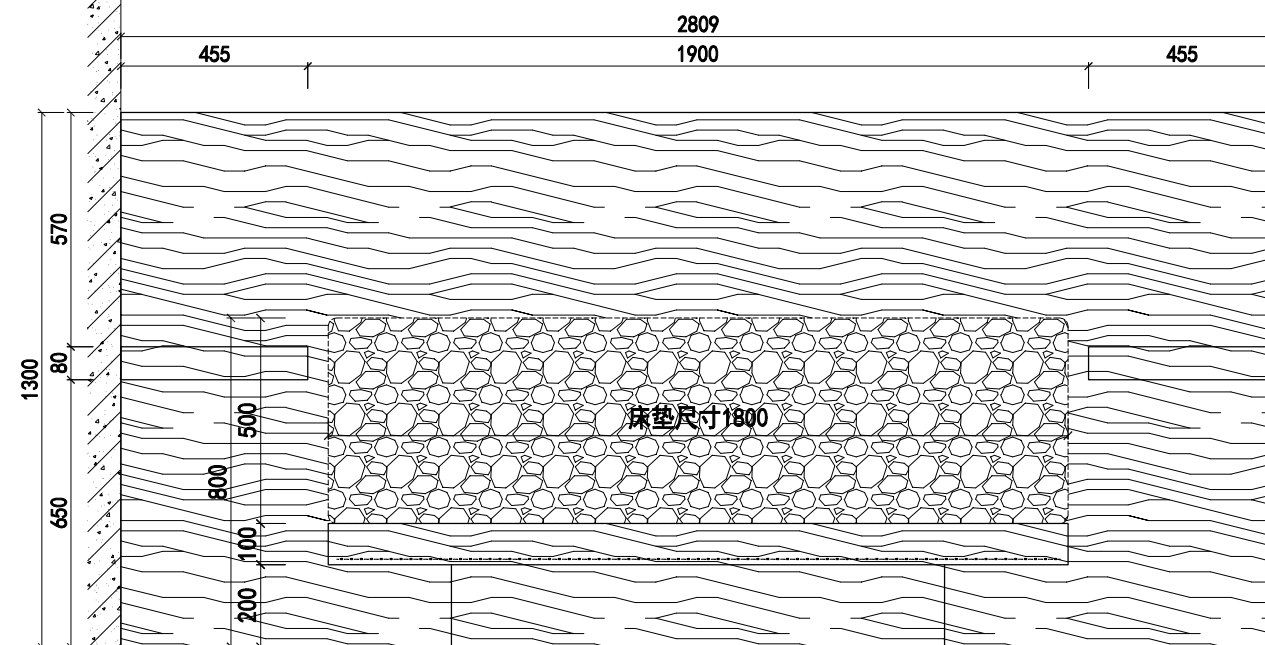

① 正立面图
比例(A3) 1:6

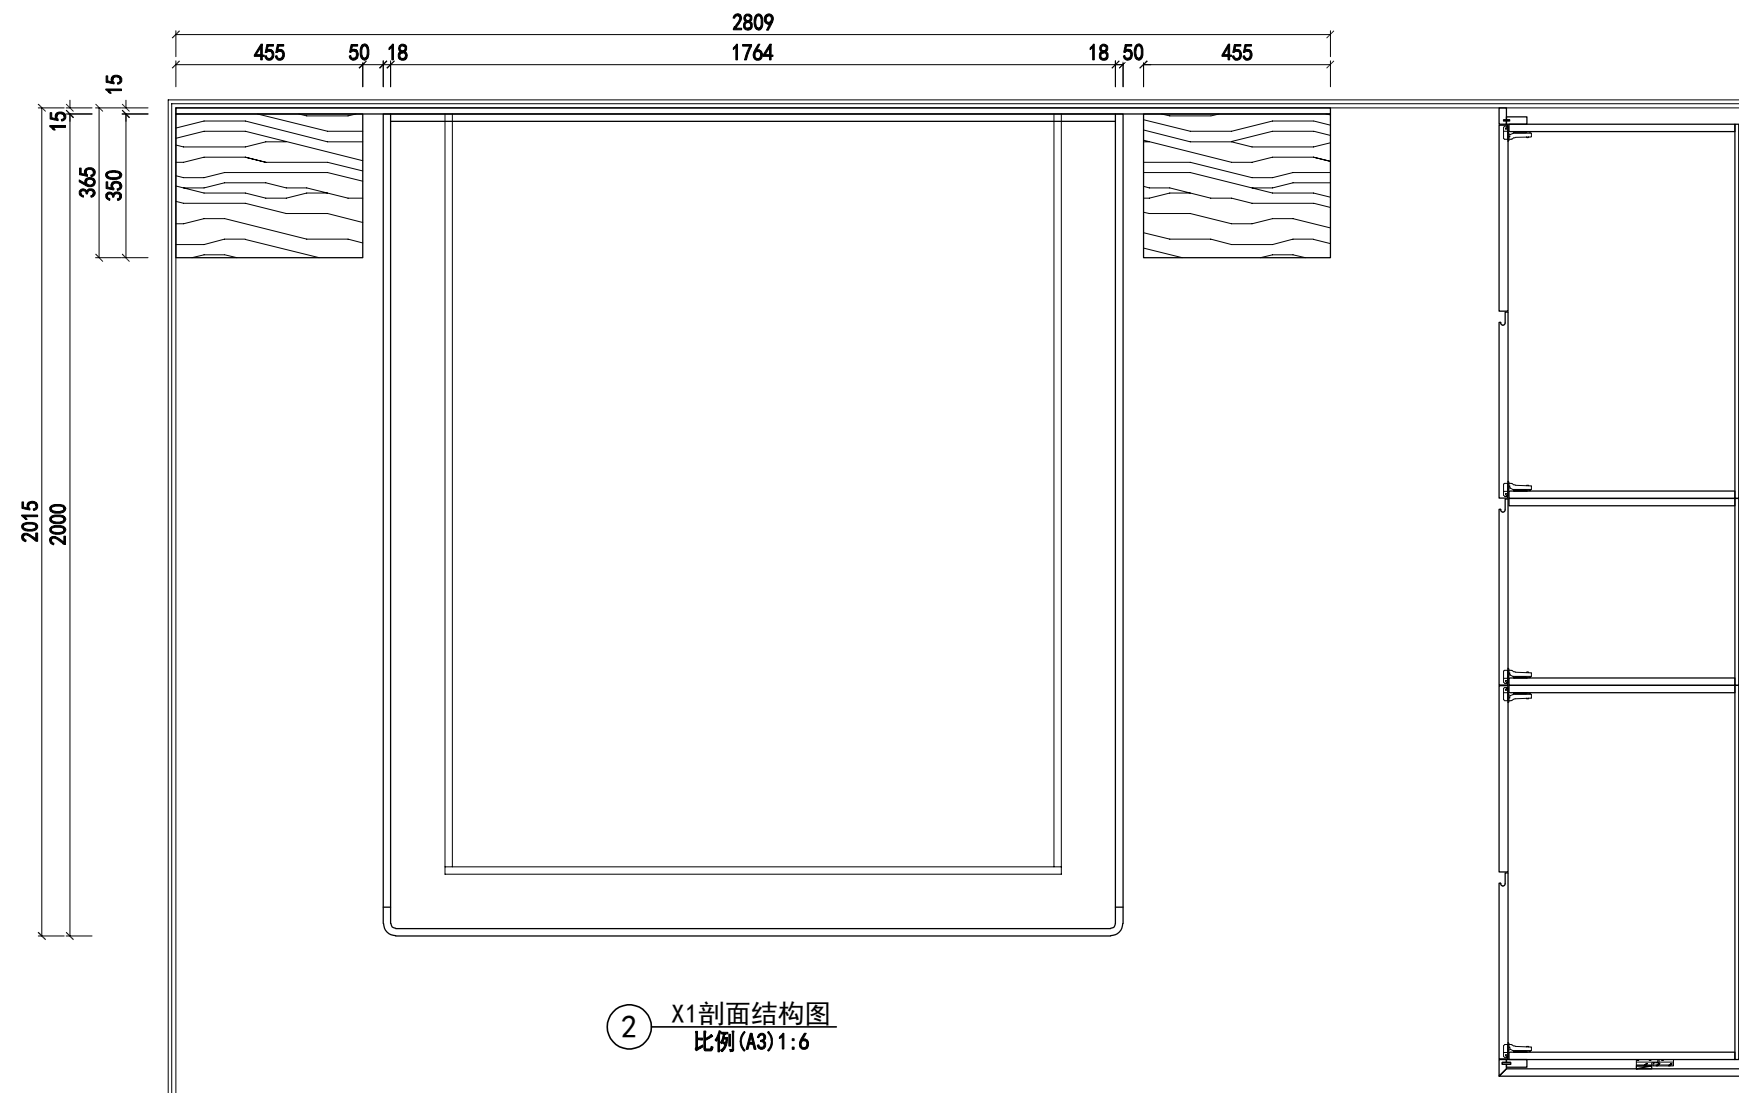

② X1剖面结构图
比例(A3) 1:6






COPYRIGHT:
ALL RIGHTS RESERVED. THIS WORK IS COPYRIGHT AND CANNOT BE REPRODUCED OR COPIED BY ANY MEANS WITHOUT THE WRITTEN PERMISSION OF RUJACH INDUSTRIES PTY LTD. ANY LICENSE, EXPRESS OR IMPLIED, TO USE THIS DOCUMENT FOR ANY PURPOSE WHATSOEVER IS RESTRICTED TO THE TERMS OF THE AGREEMENT BETWEEN RUJACH INDUSTRIES PTY LTD AND THE INSTRUCTING PARTY.


GENERAL NOTES:
USE FIGURED DIMENSIONS IN PREFERENCE TO SCALED. CONFIRM THE SCALE F HARD COPY DRAWINGS BY USING BAR. CHECK ALL DIMENSIONS ON SITE BEFORE FABRICATION OR BEFORE SET OUT.

CLIENT 建设单位	PROJECT 项目名称	巴哈马别墅		PROJECT MANAGER 项目负责人:			TITLE 图纸名称:	DISCIPLINE 专业:
	SUB-PROJECT 子项目名称	卧室2		DRAWN 制图:	AUDIT 审核:			STATUS 阶段:
				DESIGN 设计:	CHECKED 审定:			SCALE 比例: 20
				VERIFY 校对:			DRAWING NO. 图号:	DATE 日期:

   结构工程
建设电通



暖通工程
给排水工程
电气工程
弱电工程
空调工程
消防工程
安防工程
其他工程

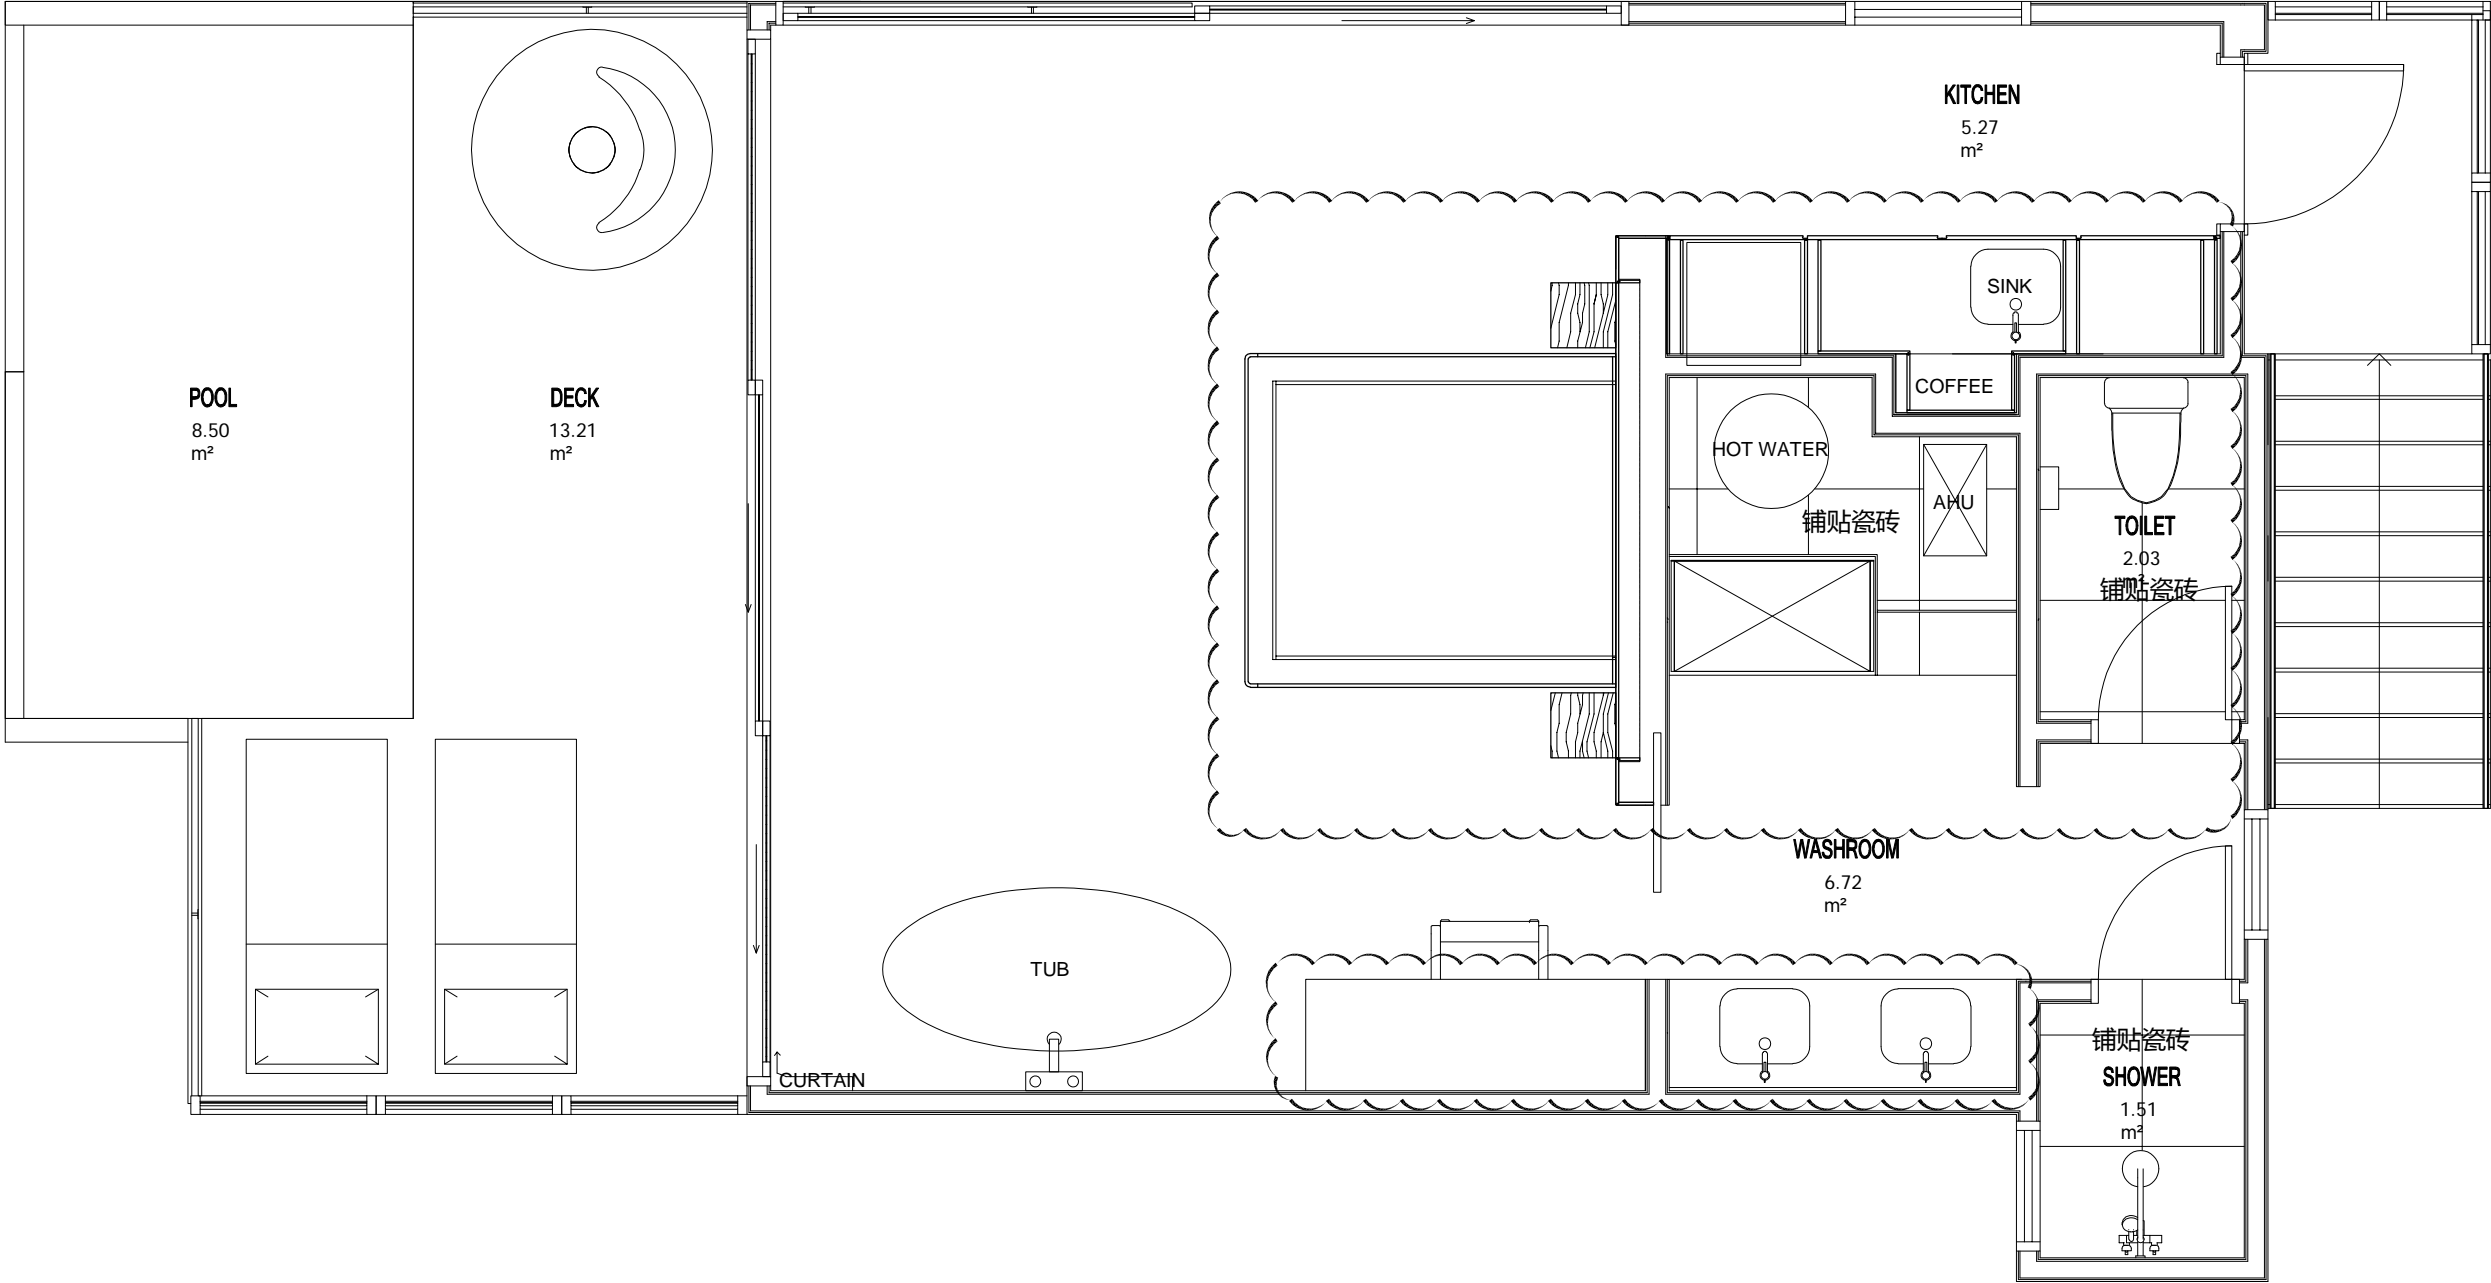

1 平面图
比例 (A3) 1:6



COPYRIGHT:
ALL RIGHTS RESERVED. THIS WORK IS COPYRIGHT AND CANNOT BE REPRODUCED OR COPIED BY ANY MEANS
WITHOUT THE WRITTEN PERMISSION OF BAHAMA HOUSEHOLD PVT LTD. ANY LICENSE, EXPRESS OR IMPLIED, TO
USE THIS DOCUMENT FOR ANY PURPOSES WITHOUT THE WRITTEN PERMISSION OF BAHAMA HOUSEHOLD PVT LTD.
AGREEMENT BETWEEN BAHAMA HOUSEHOLD PVT LTD AND THE INSTRUCTING PARTY.

GENERAL NOTES:
USE DIMENSIONS IN PREFERENCE TO SCALES. CONFIRM THE
SCALE OF DIMENSIONS BY CONSULTING ALL
DIMENSIONS ON SITE BEFORE FABRICATION OR BEFORE SET OUT.


CLIENT 建设单位	PROJECT 项目名称	巴哈马别墅
	SUB-PROJECT 子项名称	

PROJECT MANAGER 项目负责人:	AUDIT 审核:
DRAWN 制图:	CHECKED 审定:
DESIGN 设计:	VERIFY 校对:


TITLE 图纸名称:	DRAWING NO. 图号:
-------------	-----------------

DISCIPLINE 专业:	STATUS 阶段:	SCALE 比例:	DATE 日期:
		1:20	

设计	审核	校对	制图	日期
张	李	王	赵	2024.08.20
1	1	1	1	1
2	2	2	2	2
3	3	3	3	3
100	100	100	100	100

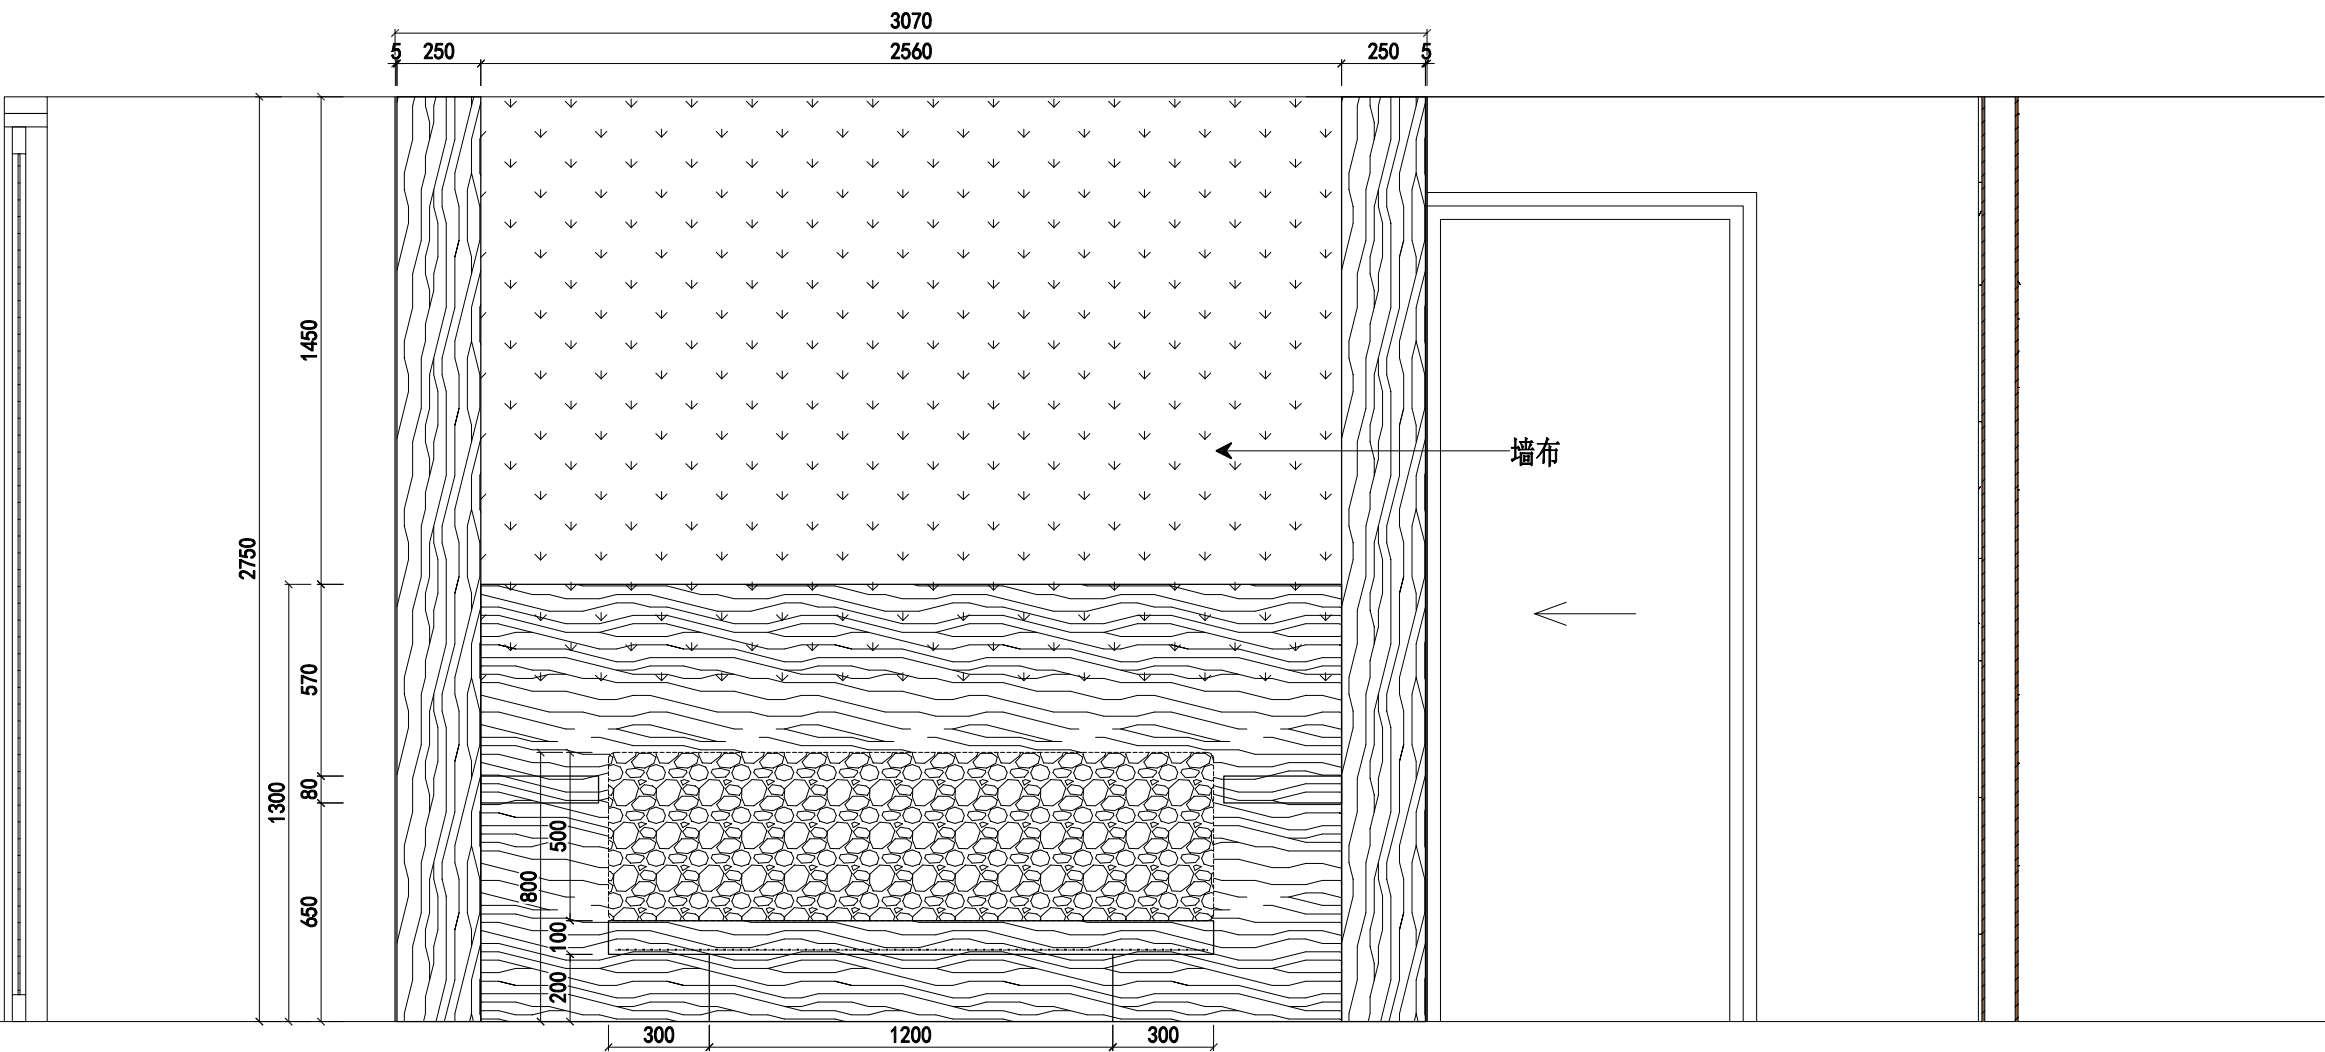

1 正立面图
比例 (A3) 1:6
3070

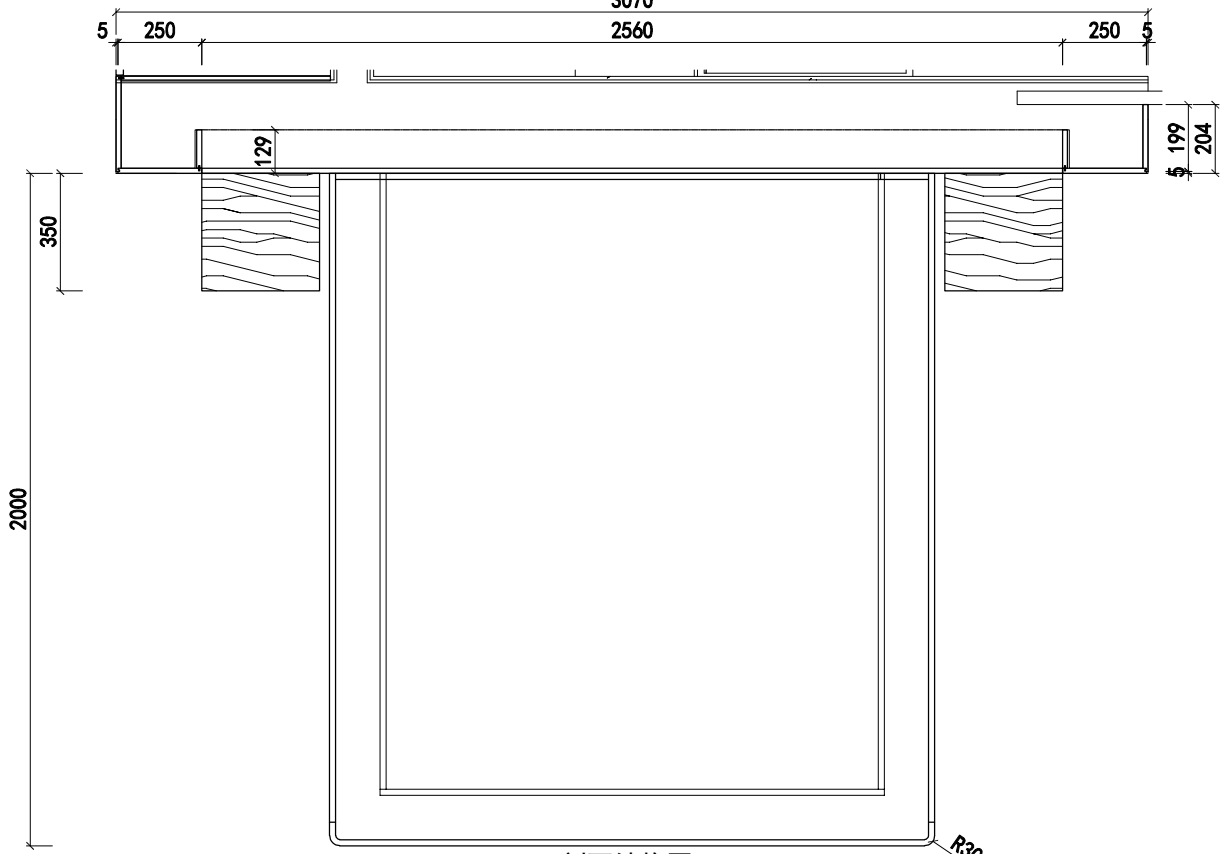


2 X1剖面结构图
比例 (A3) 1:6




COPYRIGHT:
ALL RIGHTS RESERVED. THIS WORK IS COPYRIGHT AND CANNOT BE REPRODUCED OR COPIED BY ANY MEANS
WITHOUT THE WRITTEN PERMISSION OF BAHAMA HOUSEHOLD PVT LTD. ANY LICENSE, EXPRESS OR IMPLIED, TO
USE THIS DOCUMENT FOR ANY PURPOSES WHATSOEVER IS RESTRICTED TO THE TERMS OF THE
AGREEMENT BETWEEN BAHAMA HOUSEHOLD PVT LTD AND THE INSTRUCTING PARTY.

GENERAL NOTES:
USE DIMENSIONS IN PREFERENCE TO SCALES. CONFIRM THE
SCALE OF DIMENSIONS BY DIMENSION LINES. ALL
DIMENSIONS ON SITE BEFORE FABRICATION OR BEFORE SET OUT.


CLIENT 建设单位	PROJECT 项目名称	巴哈马别墅	PROJECT MANAGER 项目负责人	TITLE 图纸名称	DISCIPLINE 专业
	SUB-PROJECT 子项名称	卧室	DRAWN 制图	AUDIT 审核	STATUS 阶段
			DESIGN 设计	CHECKED 审定	SCALE 比例 1:20
			VERIFY 校对		DRAWING NO. 图号
					DATE 日期

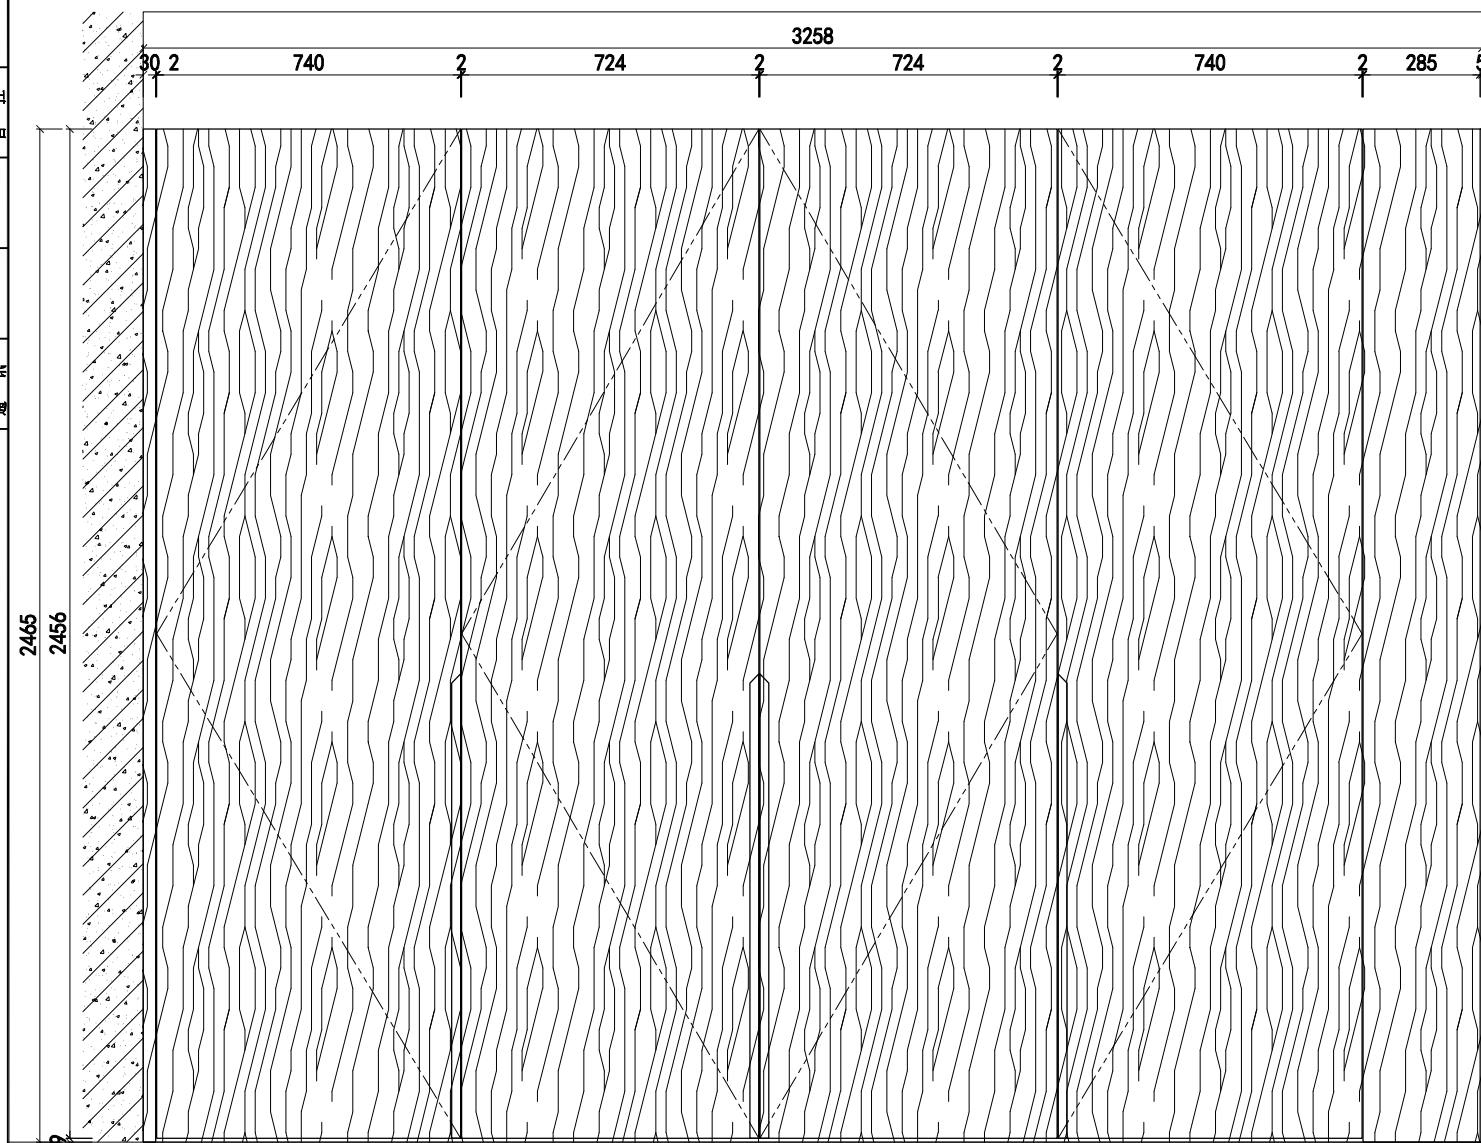

① 正立面图
比例(A3) 1:6

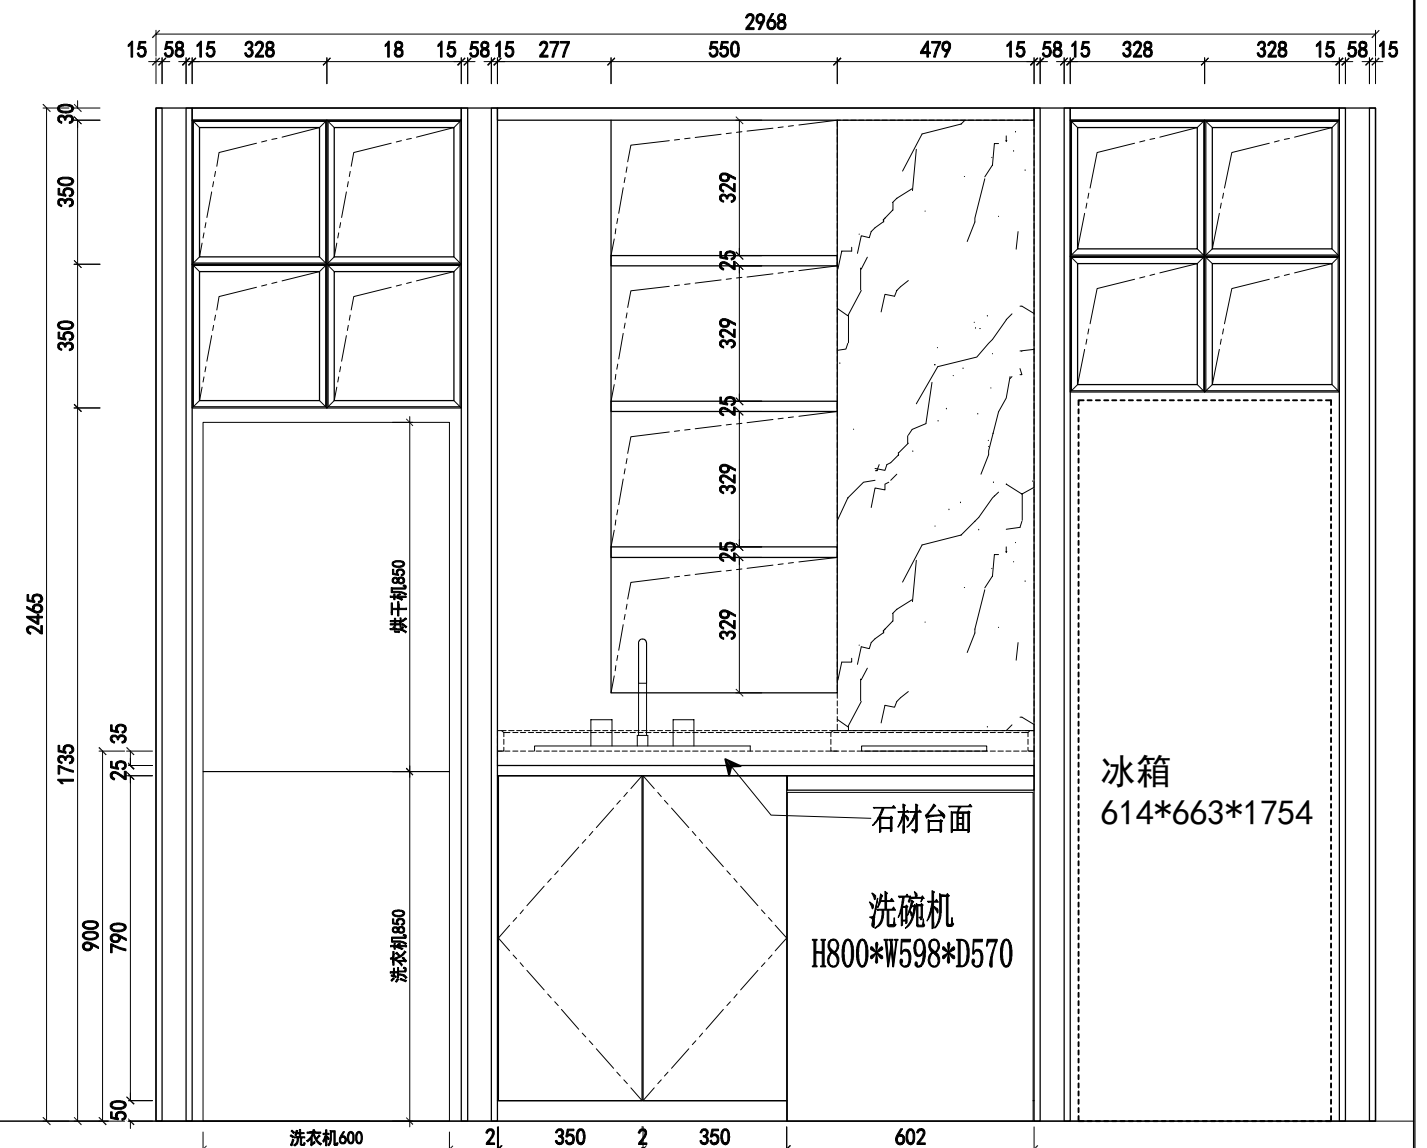

③ 内笼图
比例 (A3) 1:6

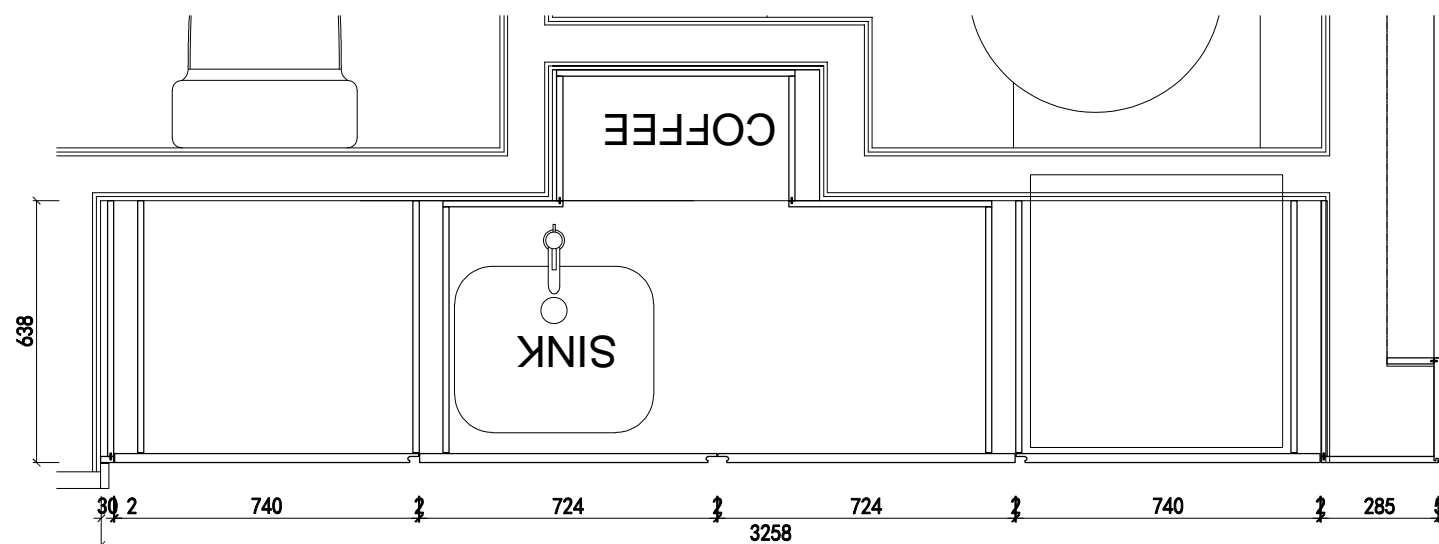


② X1剖面结构图
比例(A3) 1:6

给排水工程
暖通工程
电气工程
弱电工程
园林景观工程
室内装饰工程
其他工程



1 正立面图
比例 (A3) 1:6

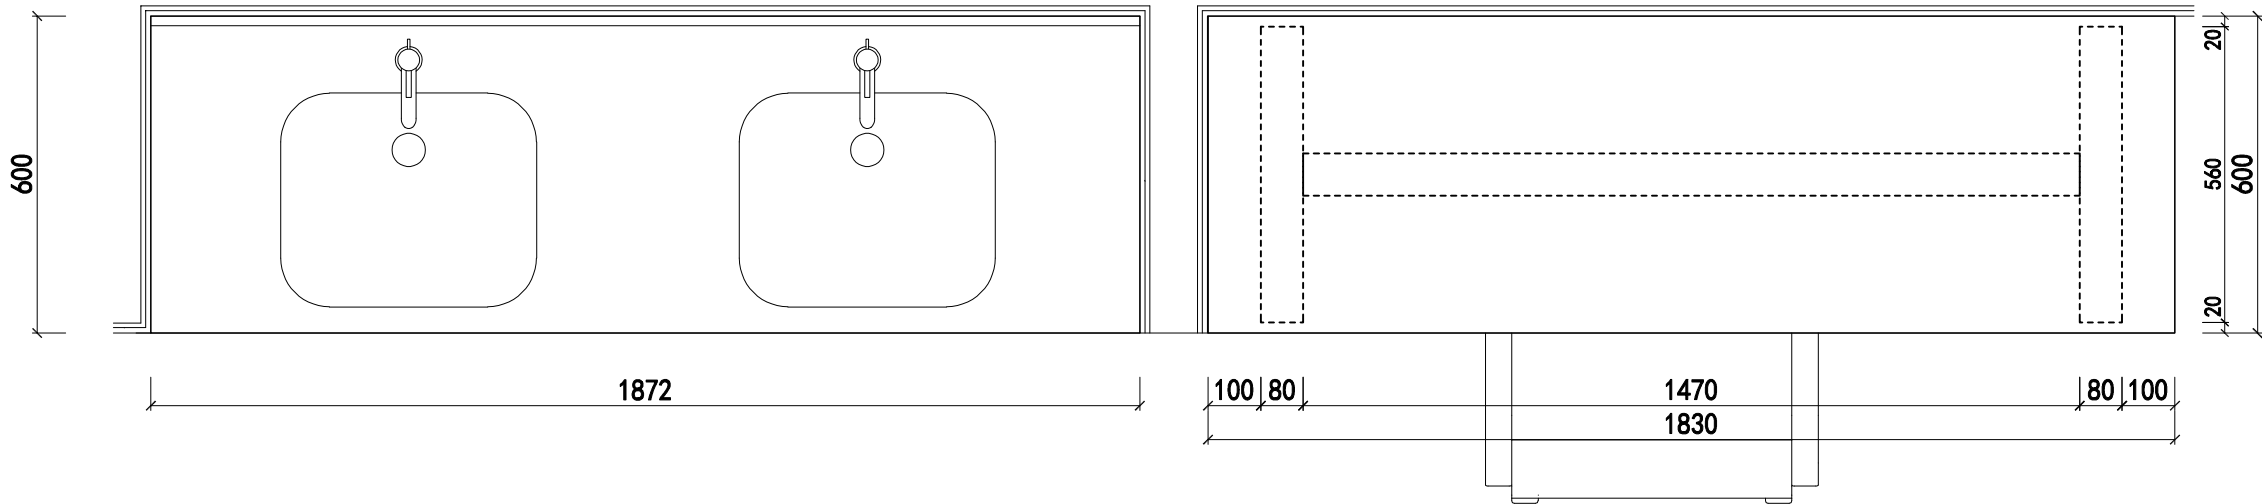

2 X1剖面结构图
比例 (A3) 1:6



COPYRIGHT:
ALL RIGHTS RESERVED. THIS WORK IS COPYRIGHT AND CANNOT BE REPRODUCED OR COPIED BY ANY MEANS
WITHOUT THE WRITTEN PERMISSION OF BAHAMA HOUSEHOLD PVT LTD. ANY LICENSE, EXPRESS OR IMPLIED, TO
USE THIS DOCUMENT FOR ANY PURPOSES WHATSOEVER IS RESTRICTED TO THE TERMS OF THE
AGREEMENT BETWEEN BAHAMA HOUSEHOLD PVT LTD AND THE INSTRUCTING PARTY.

GENERAL NOTES:
USE DIMENSIONS IN PREFERENCE TO SCALED. CONFIRM THE
SCALE & DIMENSIONS BY VISUAL CHECK. ALL
DIMENSIONS ON SITE BEFORE FABRICATION OR BEFORE SET OUT.

CLIENT 建设单位
PROJECT 项目名称
SUB-PRO. 子项名称


巴哈马别墅
台盆柜/书桌

PROJECT MANAGER 项目负责人:
DRAWN 制图:
DESIGN 设计:
VERIFY 校对:


TITLE 图纸名称:
DRAWING NO. 图号:

DISCIPLINE 专业:
STATUS 阶段:
SCALE 比例: 20
DATE 日期:


建筑电气	给排水工程	暖通工程	
建筑电气工程	给排水工程	暖通工程	
建筑电气工程	给排水工程	暖通工程	
建筑电气工程	给排水工程	暖通工程	

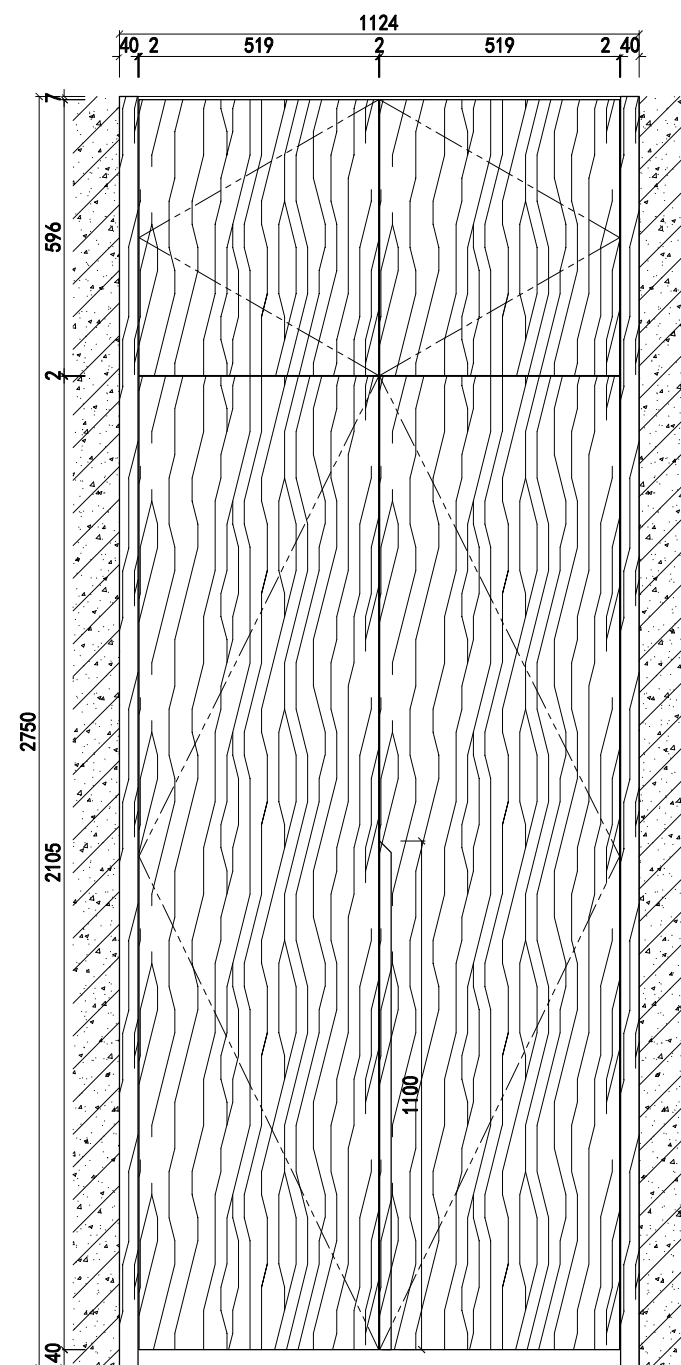

① 正立面图
比例(A3) 1:6

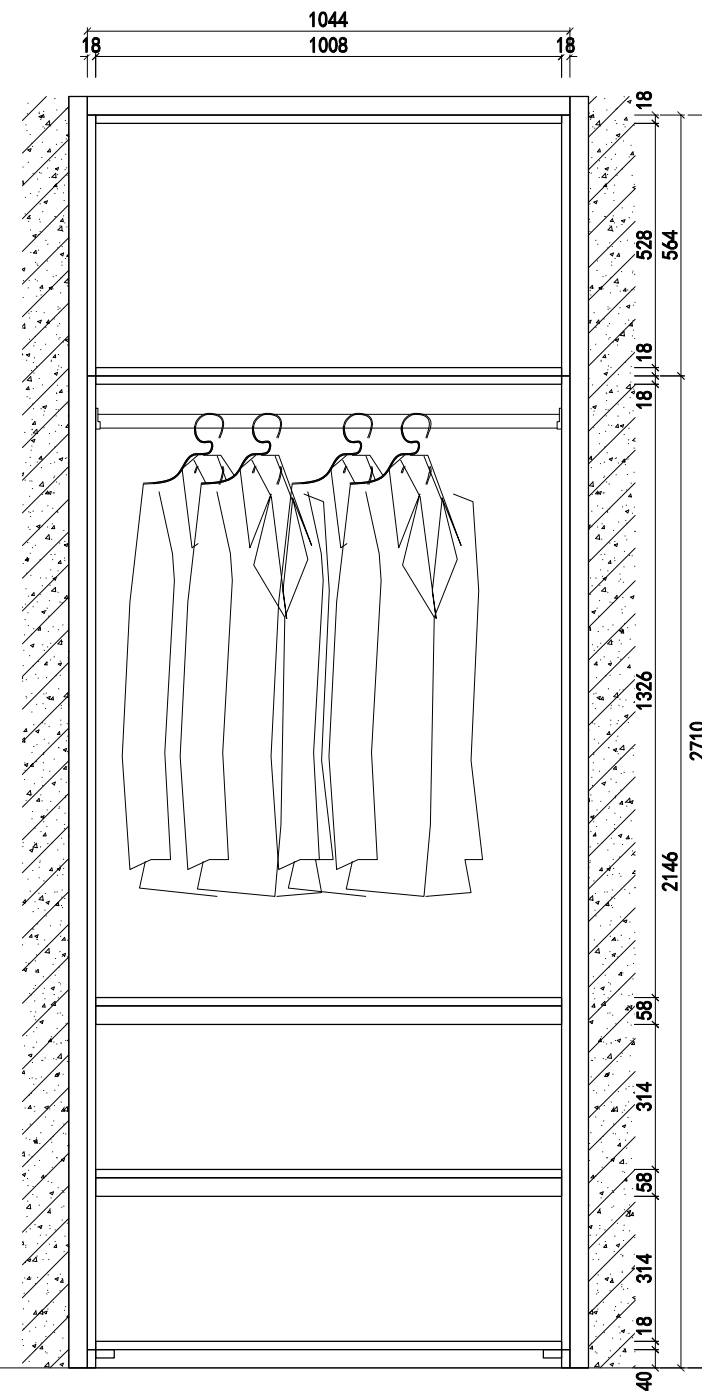

3 内笼图
比例(A3) 1:6

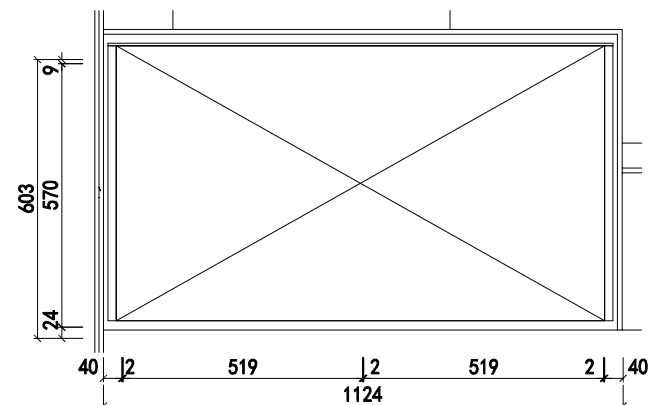

② X1剖面结构图
比例(A3) 1:6



COPYRIGHT:
ALL RIGHTS RESERVED. THIS WORK IS COPYRIGHT AND CANNOT BE REPRODUCED OR COPIED BY ANY MEANS WITHOUT THE WRITTEN PERMISSION OF RUJACH INDUSTRIES PTY LTD. ANY LICENSE, EXPRESS OR IMPLIED, TO USE THIS DOCUMENT FOR ANY PURPOSE WHATSOEVER IS RESTRICTED TO THE TERMS OF THE AGREEMENT BETWEEN RUJACH INDUSTRIES PTY LTD AND THE INSTRUCTING PARTY.

GENERAL NOTES:
USE FIGURED DIMENSIONS IN PREFERENCE TO SCALED. CONFIRM THE SCALE F HARD COPY DRAWINGS BY USING/ARCHECK ALL DIMENSIONS ON SITE BEFORE FABRICATION OR BEFORE SET OUT.

CLIENT 建设单位	PROJECT 项目名称	巴哈马别墅		PROJECT MANAGER 项目负责人:	TITLE 图纸名称:	DISCIPLINE 专业:
	SUB-PROJECT 子项目名称	DESIGN 设计:	AUDIT 审核:			STATUS 阶段:
		VERIFY 校对:	CHECKED 审定:			SCALE 比例: 20
		DRAWING NO. 图号:	DATE 日期:			